


Rev.	Date	Name	Appr.	Description
g	5.4.2012	ARV	AOK	ADDED CONDENSATE REMOVINGS TO AIR PREHEATER'S AUX. STEAM SUPPLY PIPES
h	27.9.2012	ARV	AOK	AS BUILT
*				

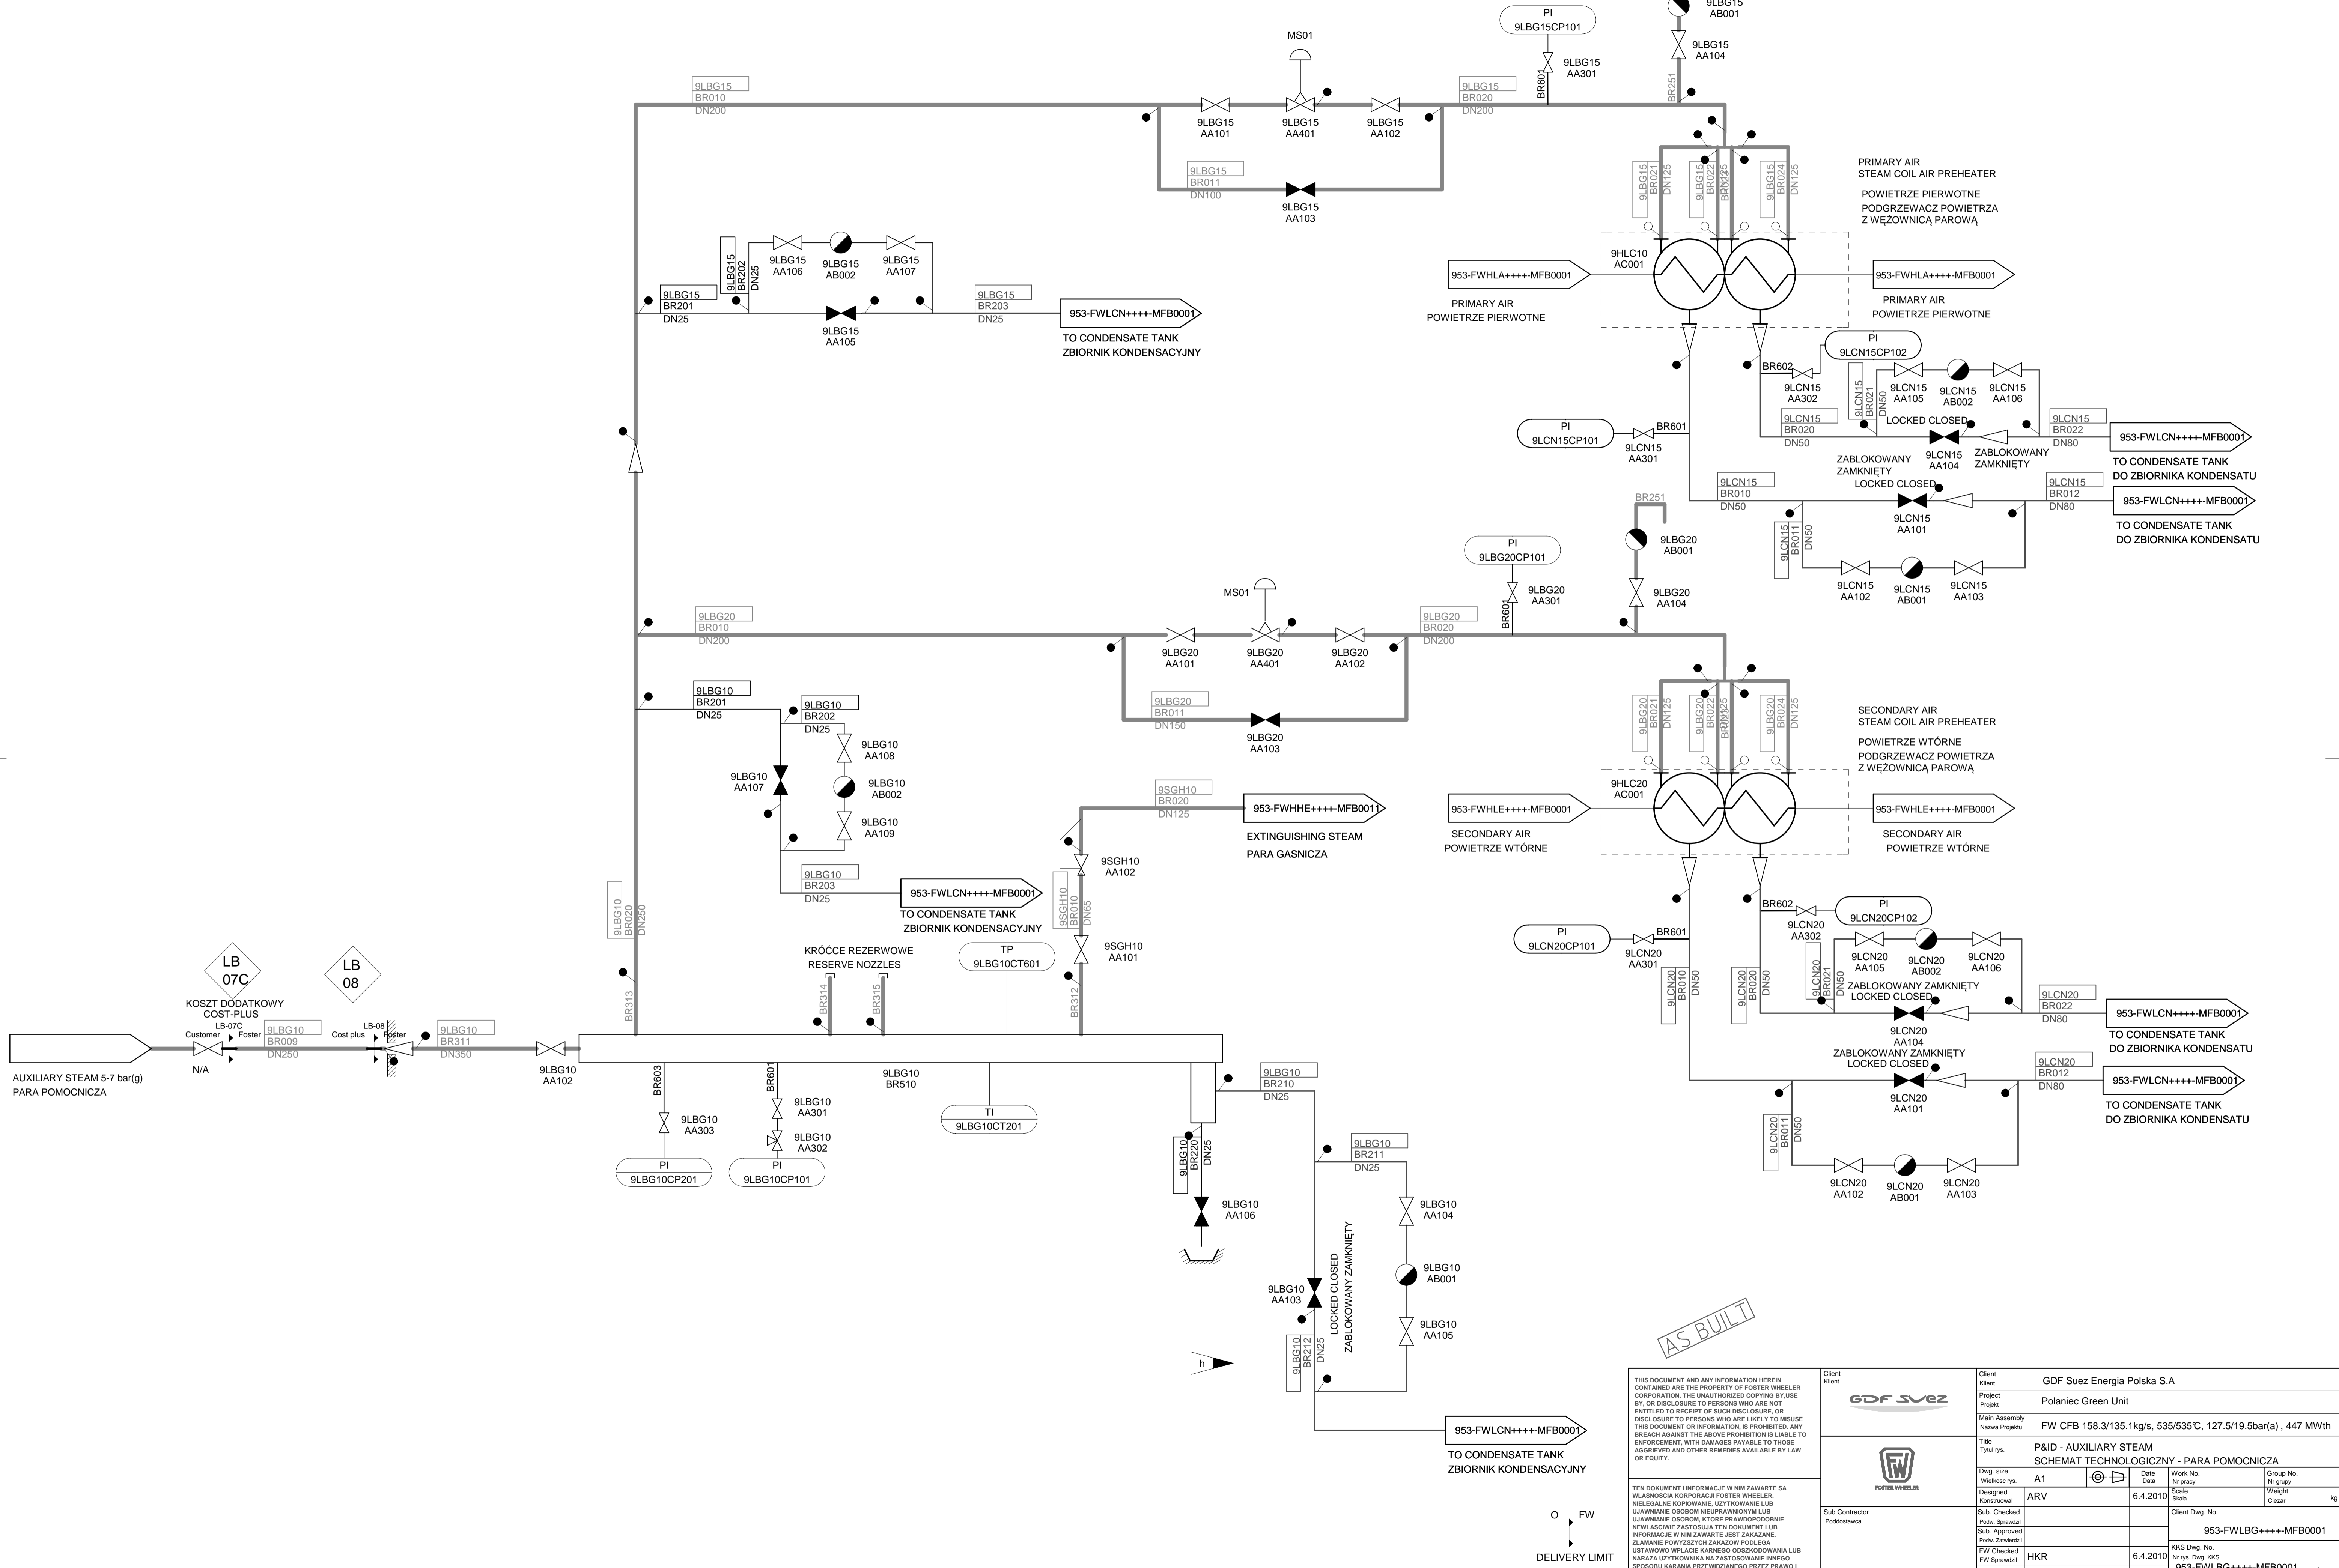

AS BUILT

DELIVERY LIMIT
GRANICA DOSTAWY

FW

Client: GDF Suez Energia Polska S.A.
Project: Polaniec Green Unit
Main Assembly: FW CFB 158.3/135.1kg/s, 535/535°C, 127.5/19.5bar(a), 447 MWth
Title: P&ID - AUXILIARY STEAM SCHEMAT TECHNOLOGICZNY - PARA POMOCNICZA
Dwg. size: A1
Date: 6.4.2010
Designed: ARV
Sub. Checked: HKR
Sub. Approved: AOK
Date: 6.4.2010
Client Dwg. No.: 953-FWLBG++++MFB0001
KKS Dwg. No.: 953-FWLBG++++MFB0001
Group No.: h